


WAKABACHO WHARF 01

1 階平面図

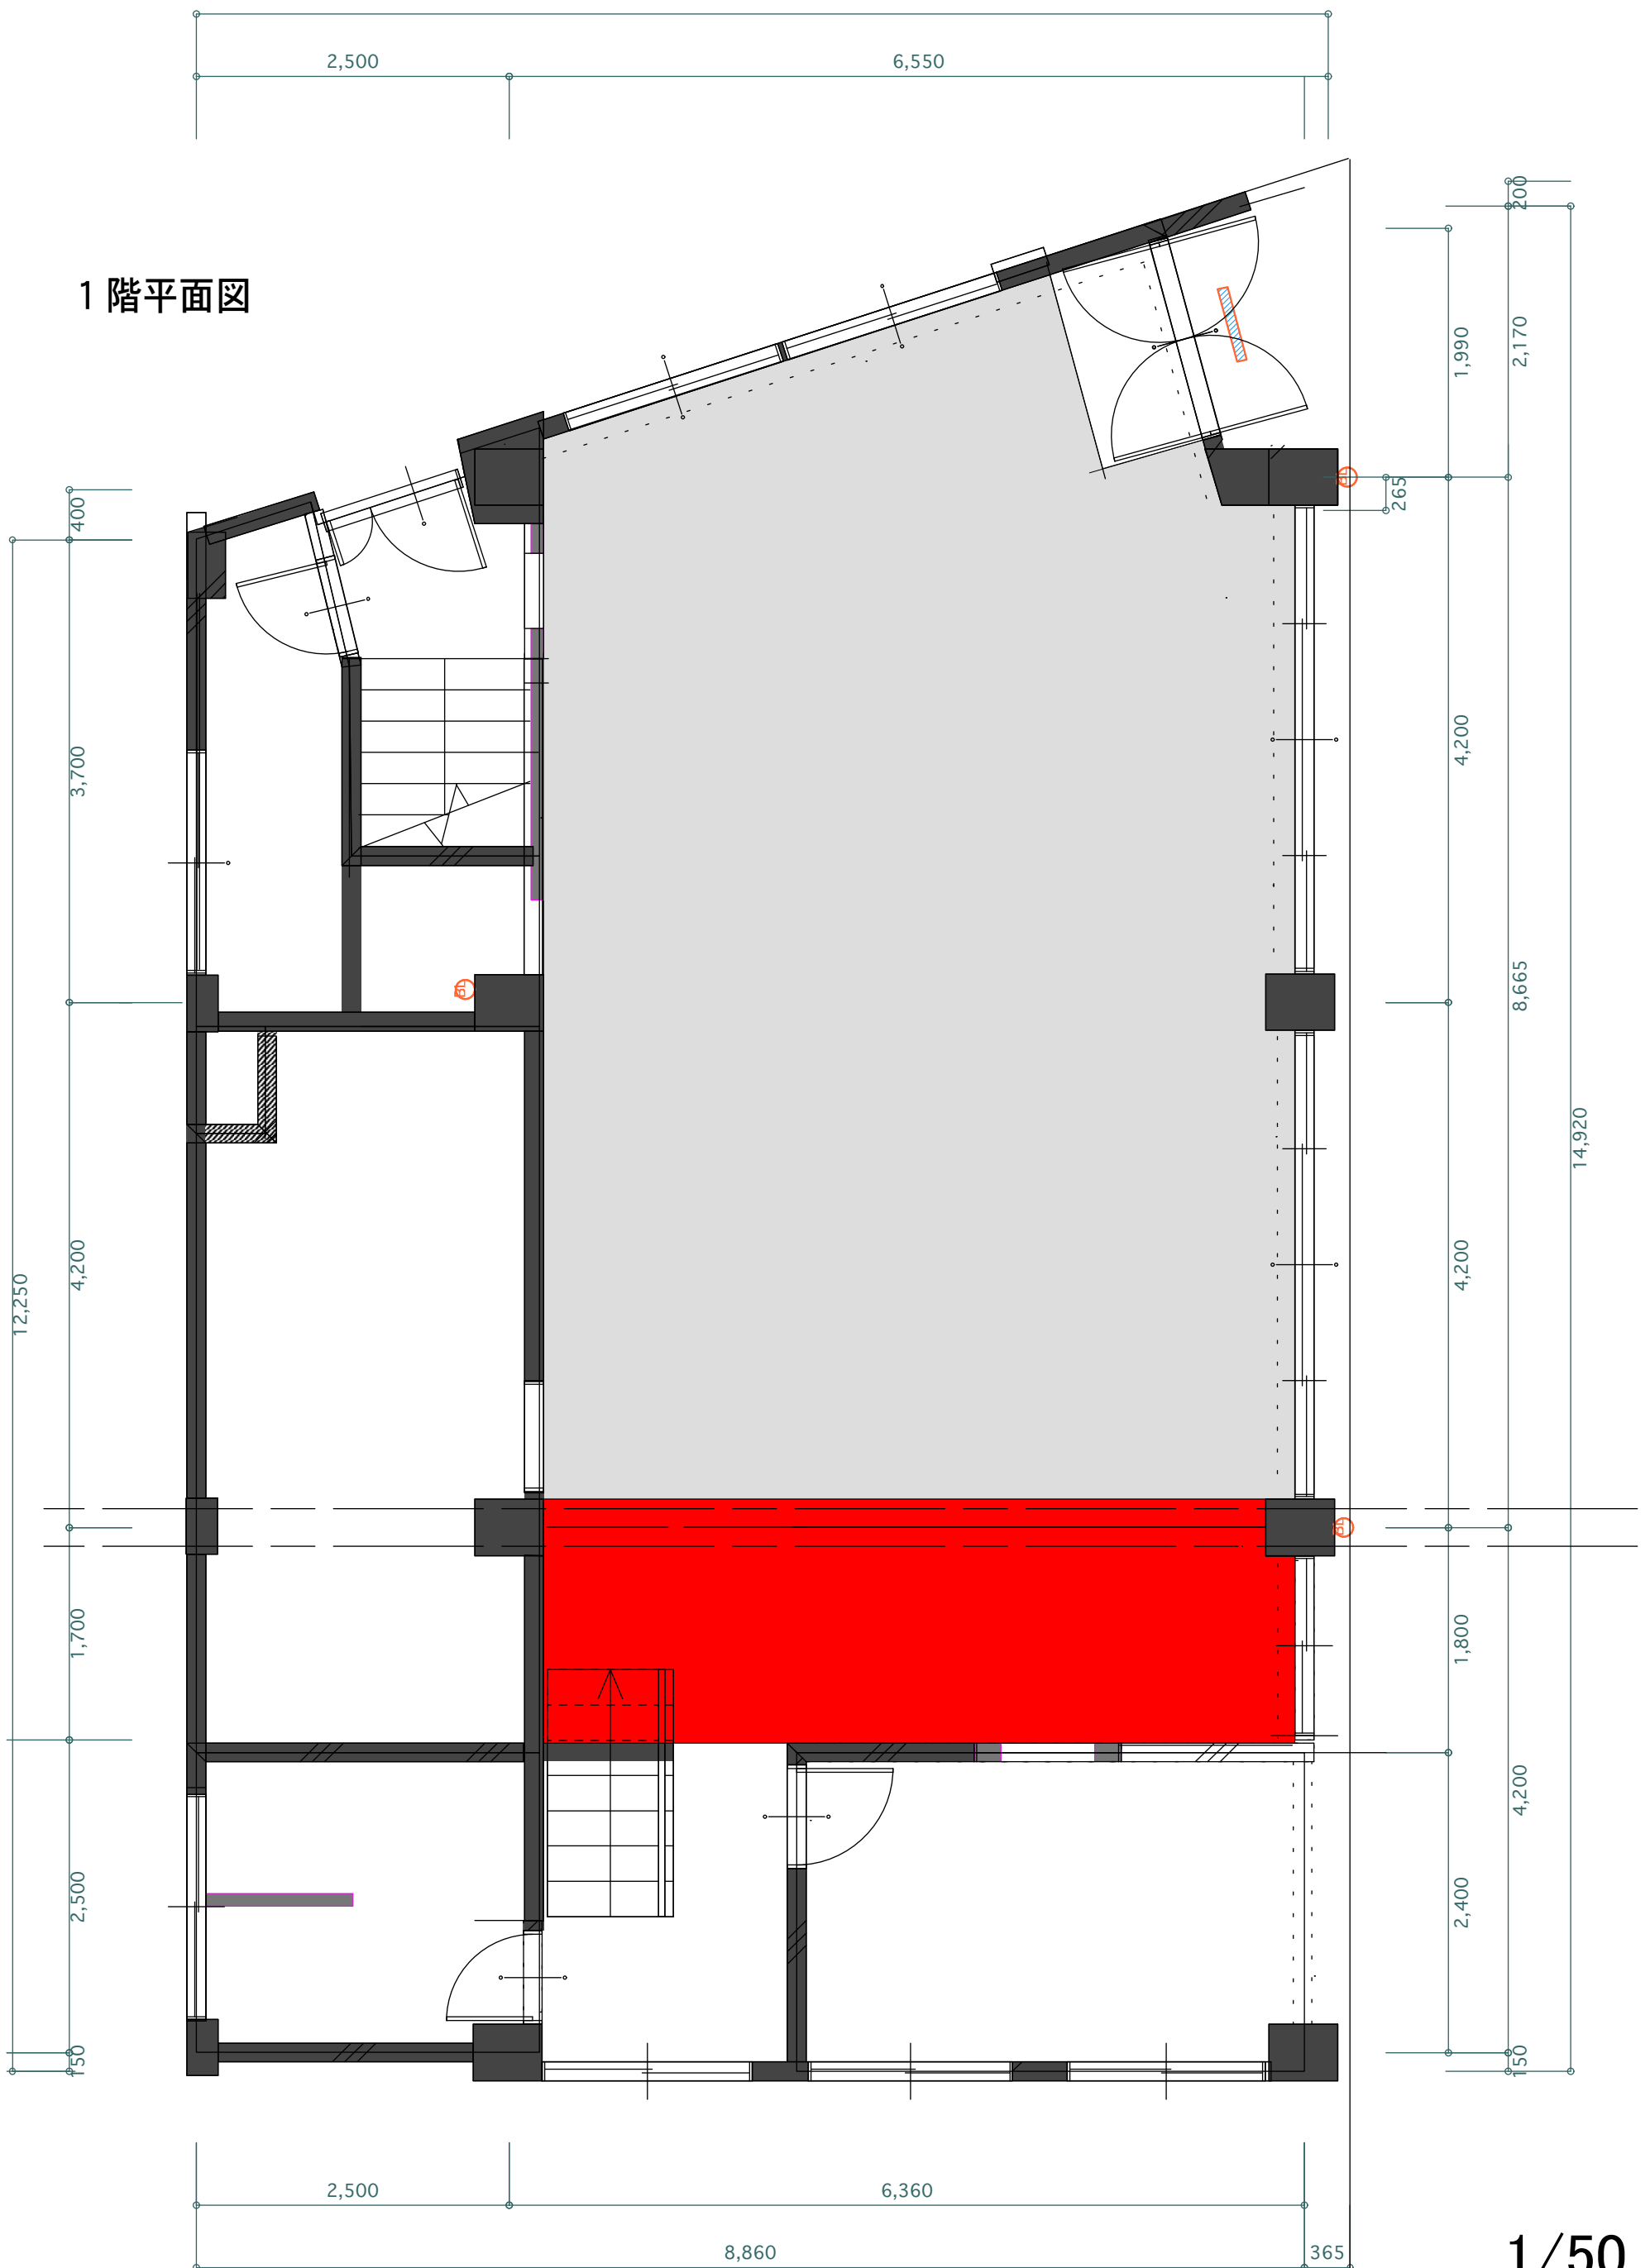


* 詳細寸法は実測してください。

1/50

2017.07.18

WAKABACHO WHARF 01


2階平面図

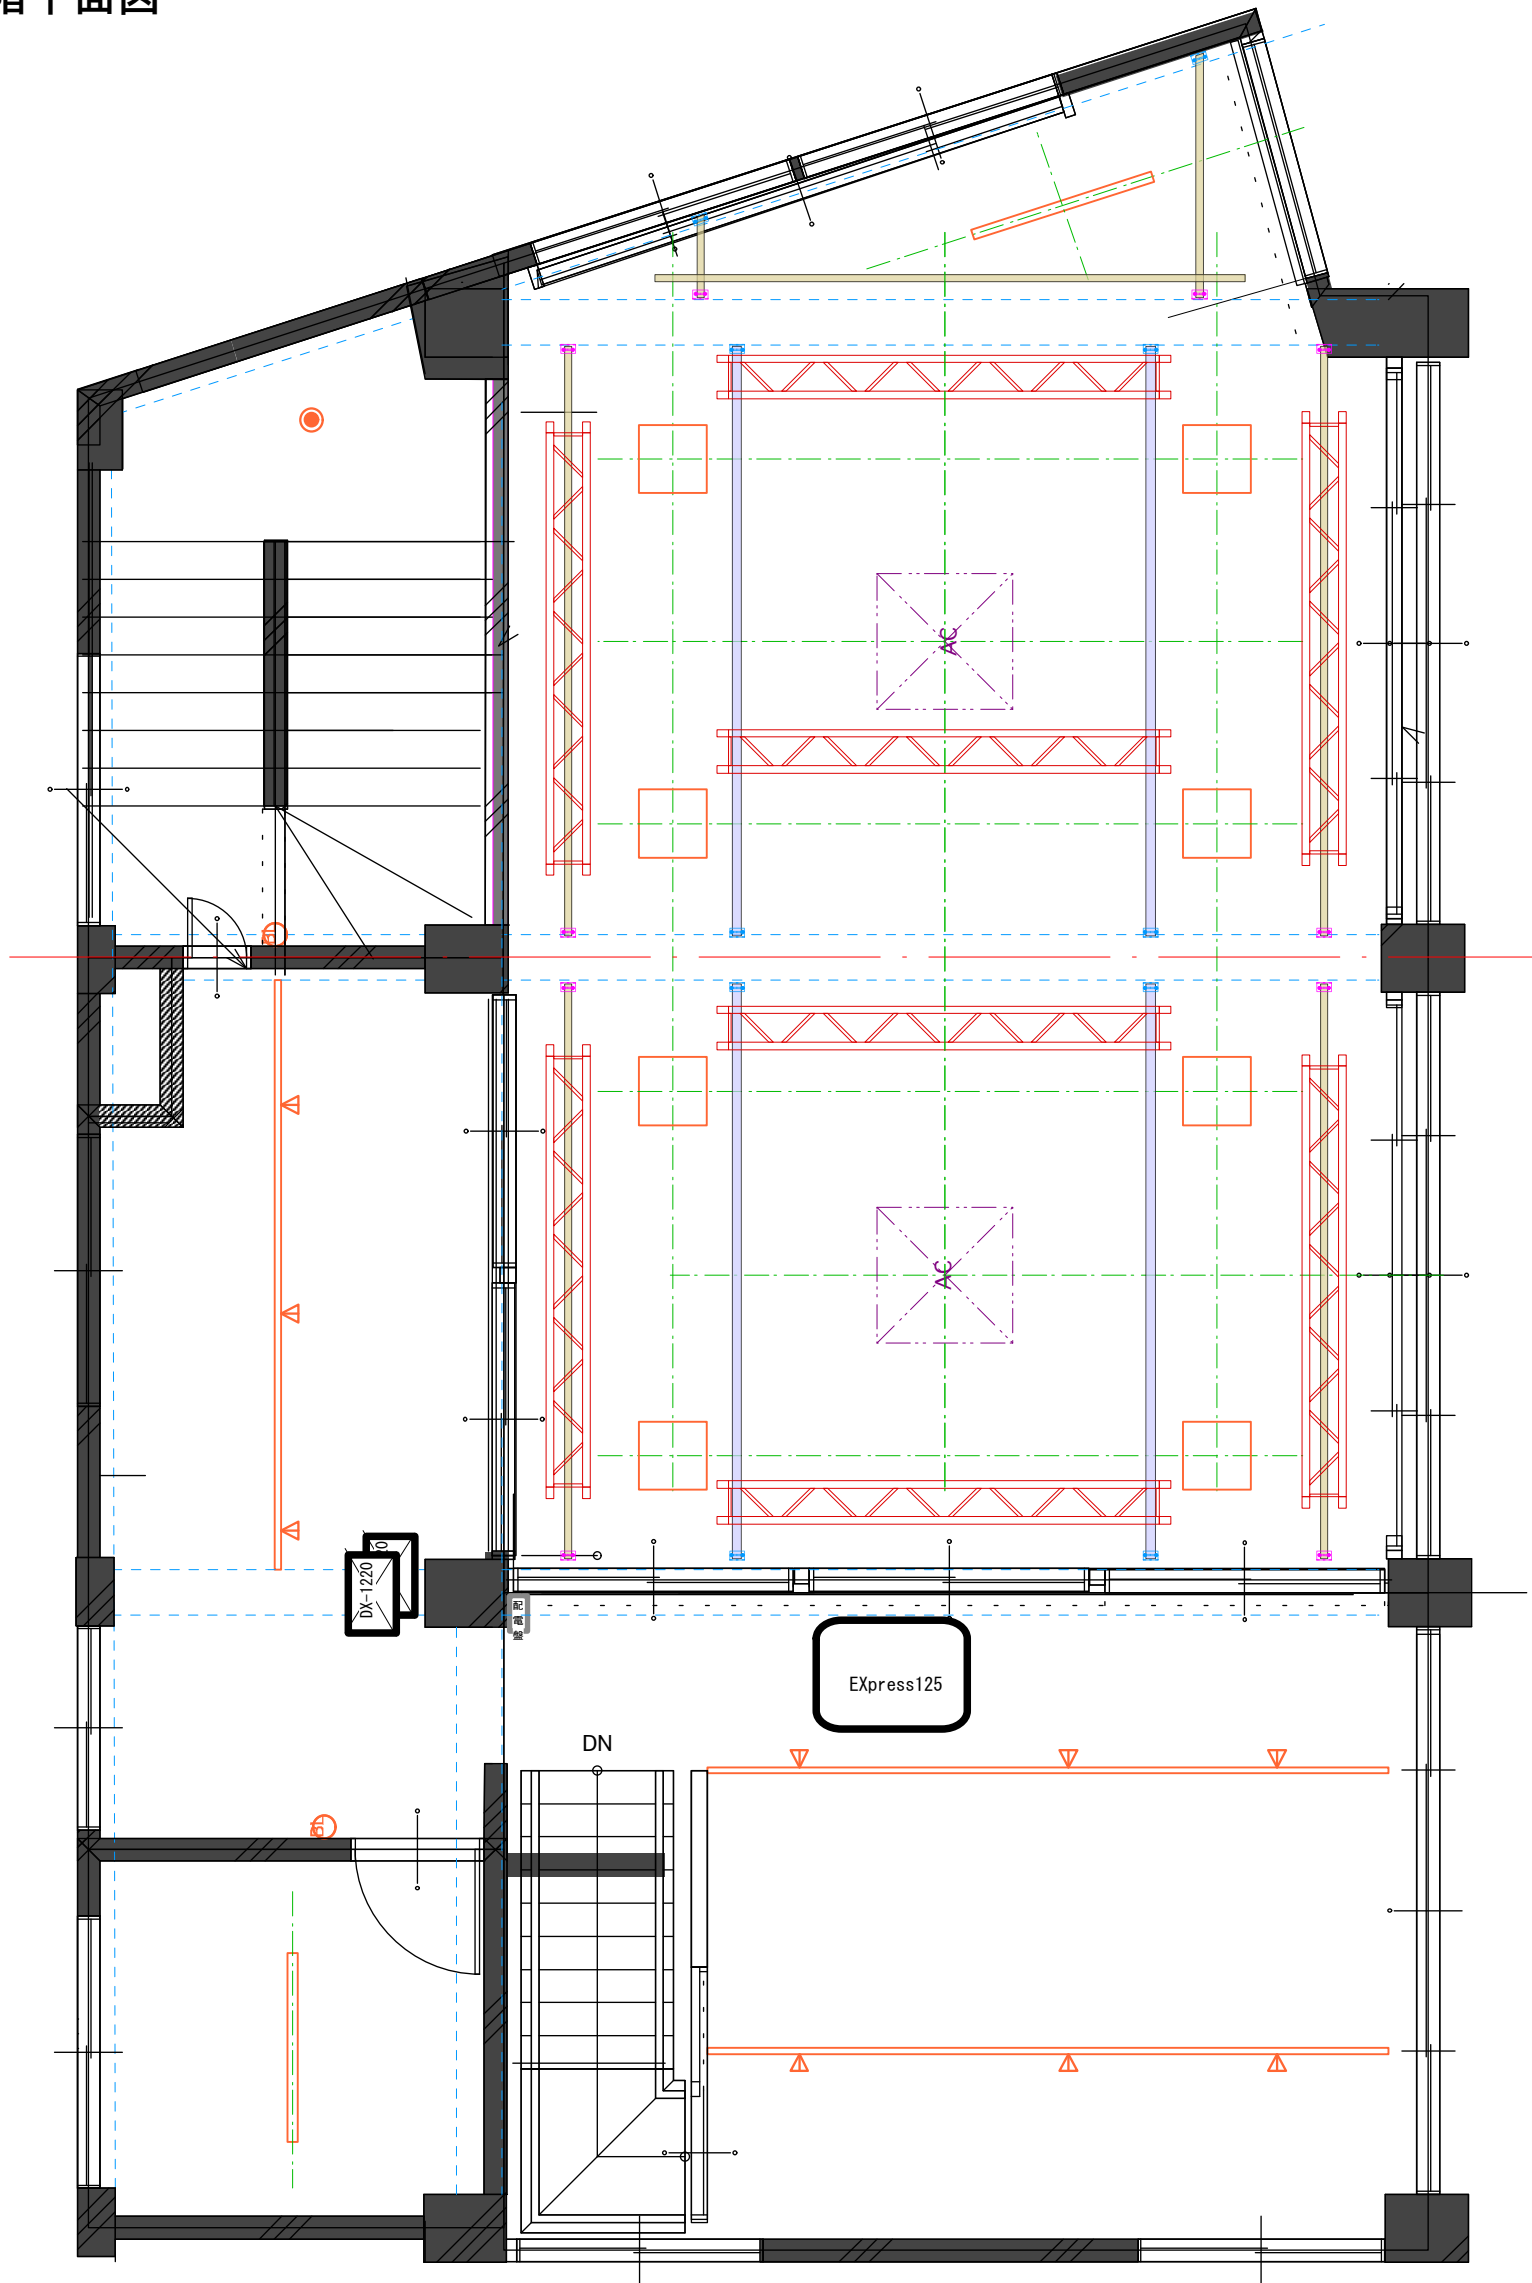

WAKABACYO WHARF

照明基本仕込み図

縮尺 1/50

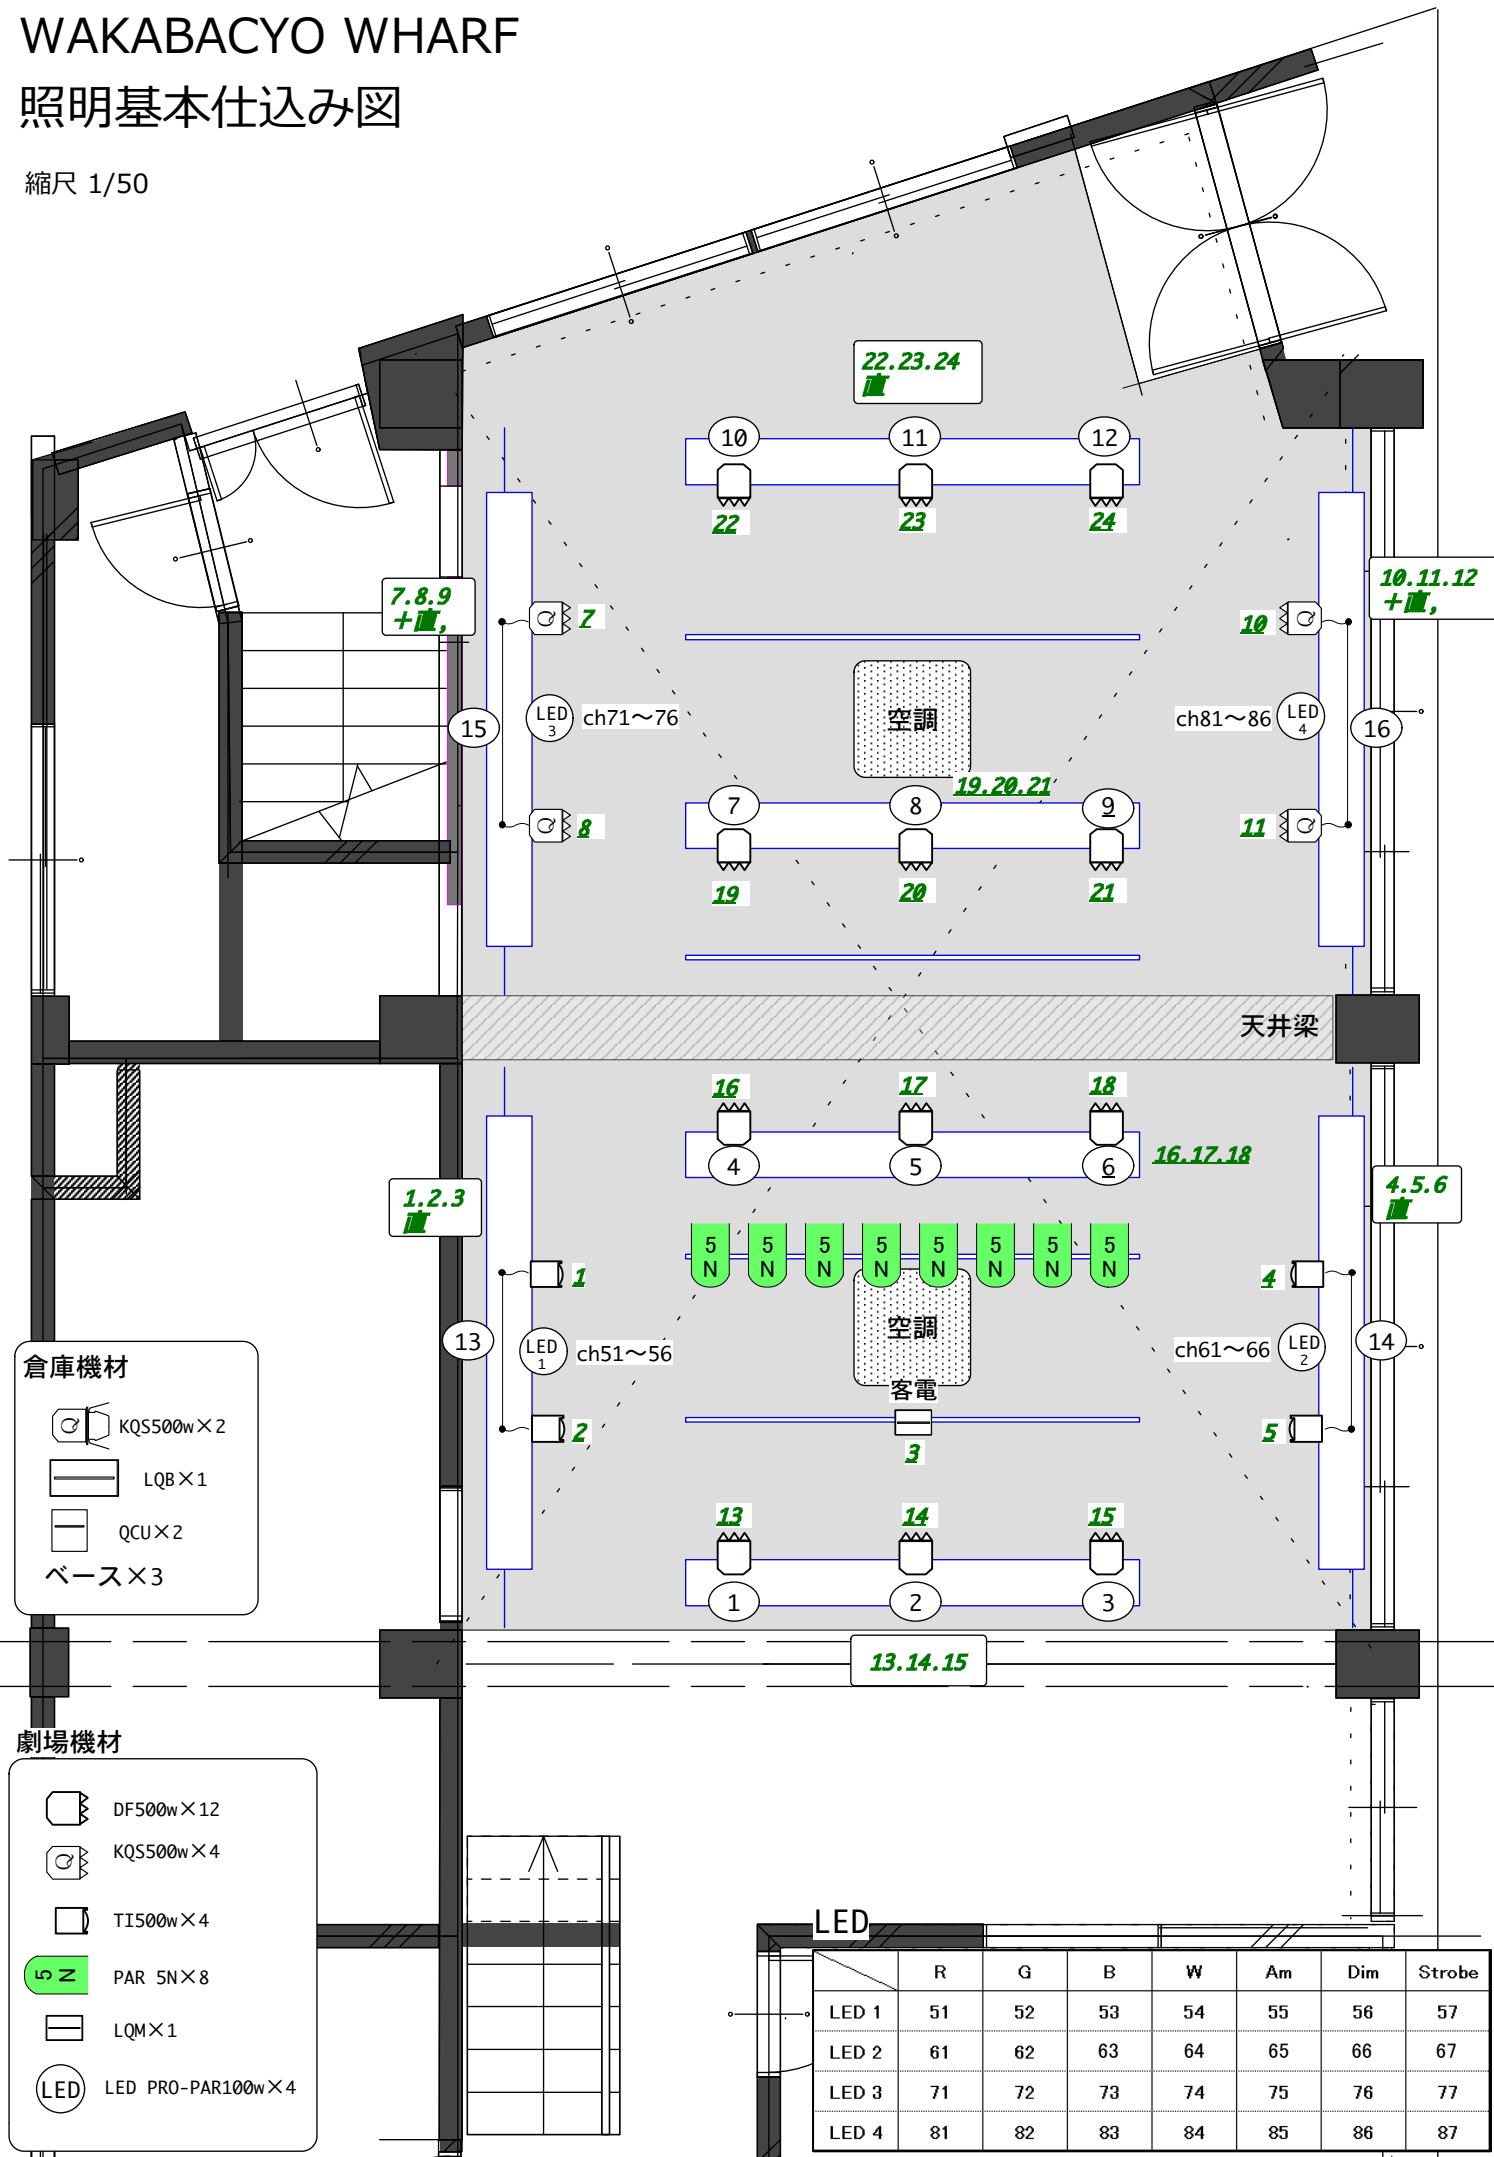

倉庫機材

- KQS500w×2
- LQB×1
- QCU×2
- ベース×3


劇場機材

- DF500w×12
- KQS500w×4
- TI500w×4
- PAR 5N×8
- LQM×1
- LED PRO-PAR100w×4

LED

	R	G	B	W	Am	Dim	Strobe
LED 1	51	52	53	54	55	56	57
LED 2	61	62	63	64	65	66	67
LED 3	71	72	73	74	75	76	77
LED 4	81	82	83	84	85	86	87

WAKABACHO WHARF 01

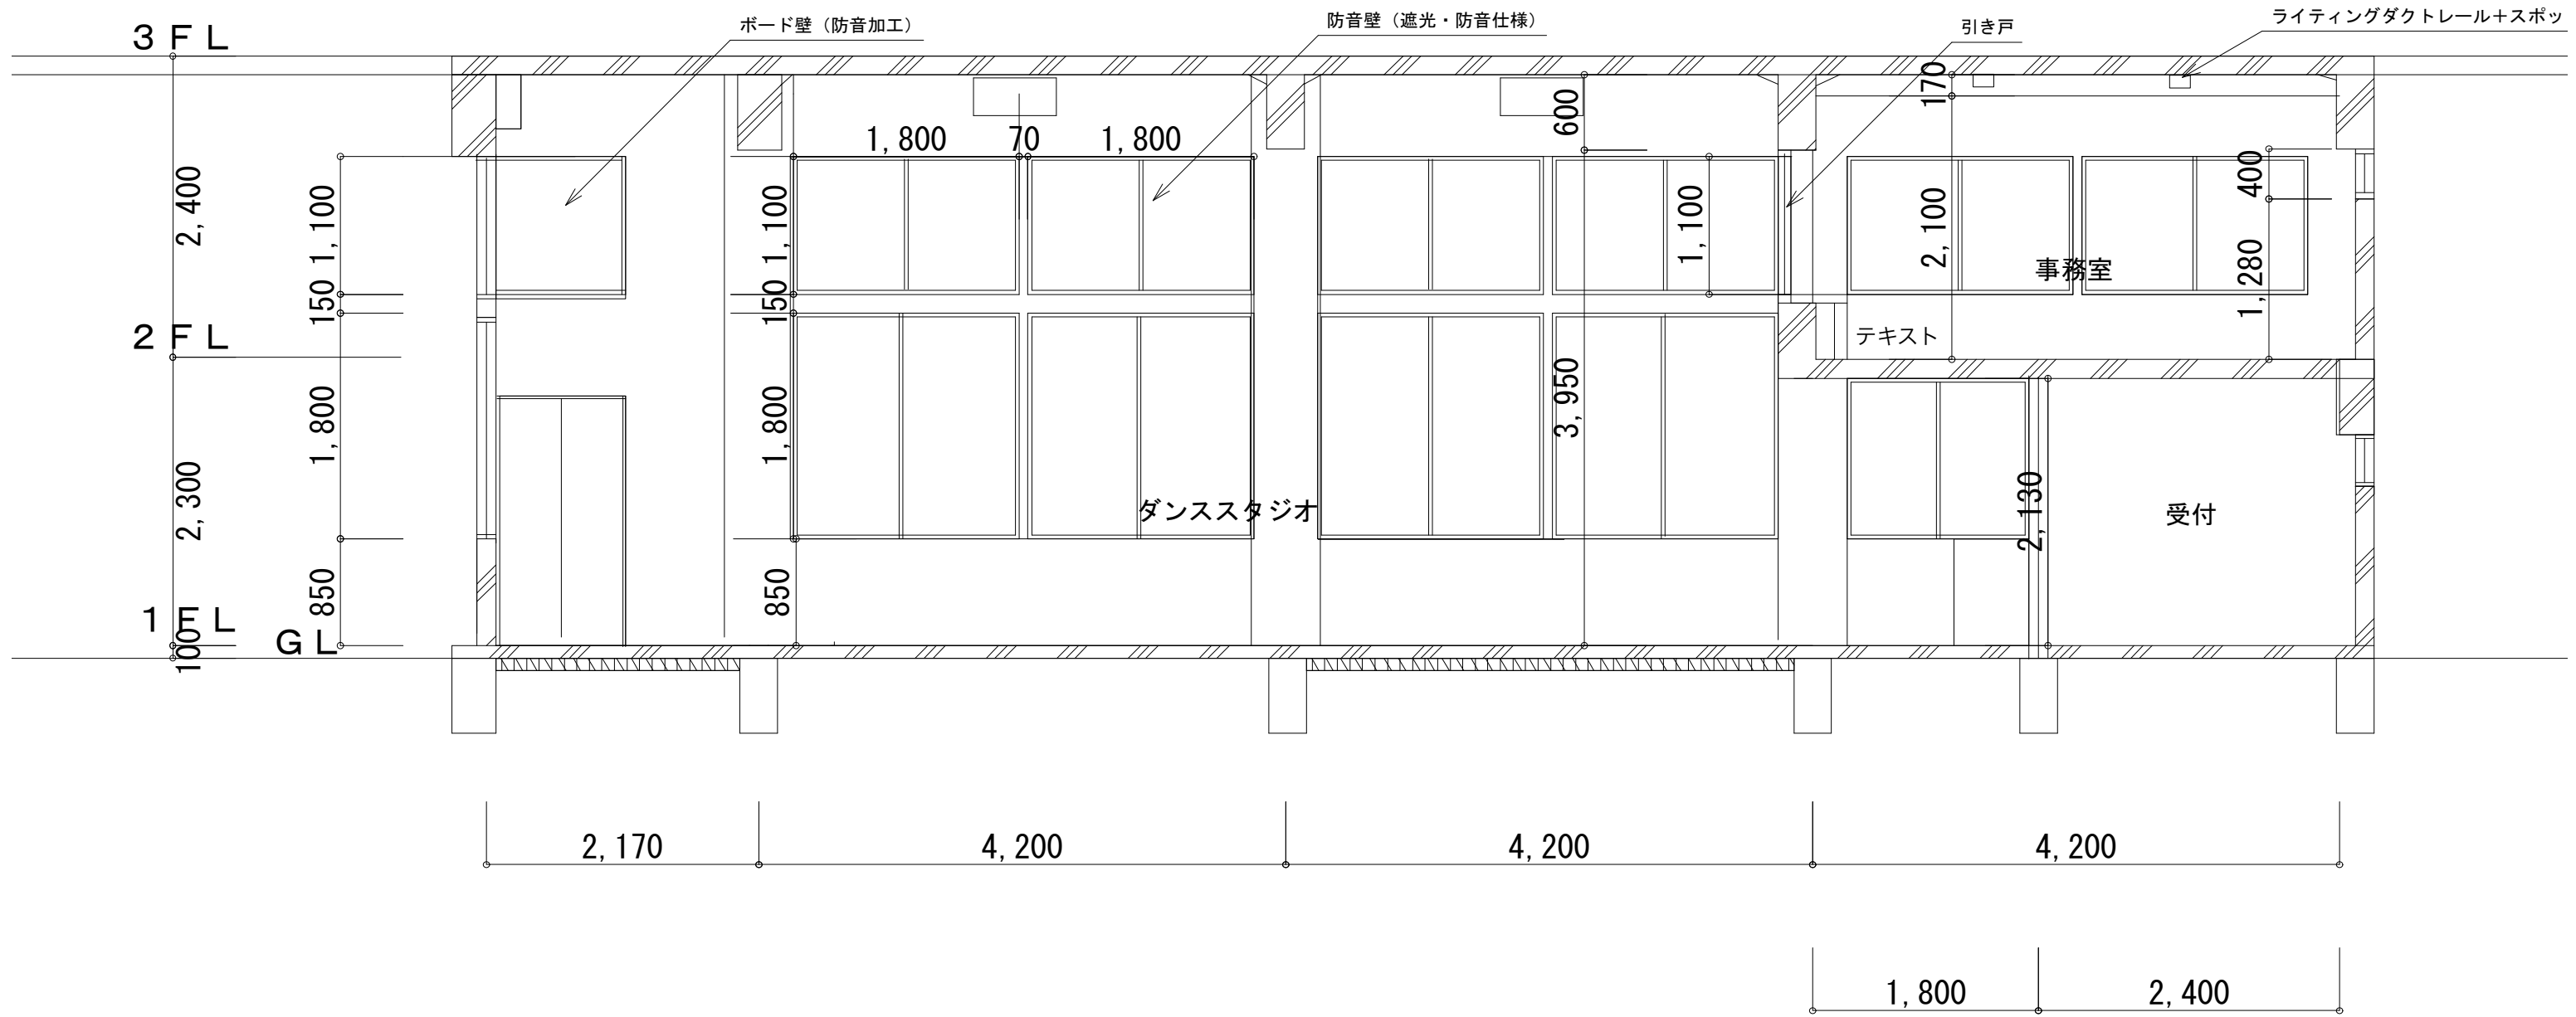

1階・2階 劇場展開図 東側縮尺1/50